


PREPARED FOR:
<< Client Name >>
1234 Any St.
Some City, XX
TEL (987) 123-4567
FAX (987) 123-4568

www.yourwebsite.com

9876 SOME ST
NEW YORK, NY

FIRST FLOOR
(As Measured: March 2008)

ELECTRICAL PLAN

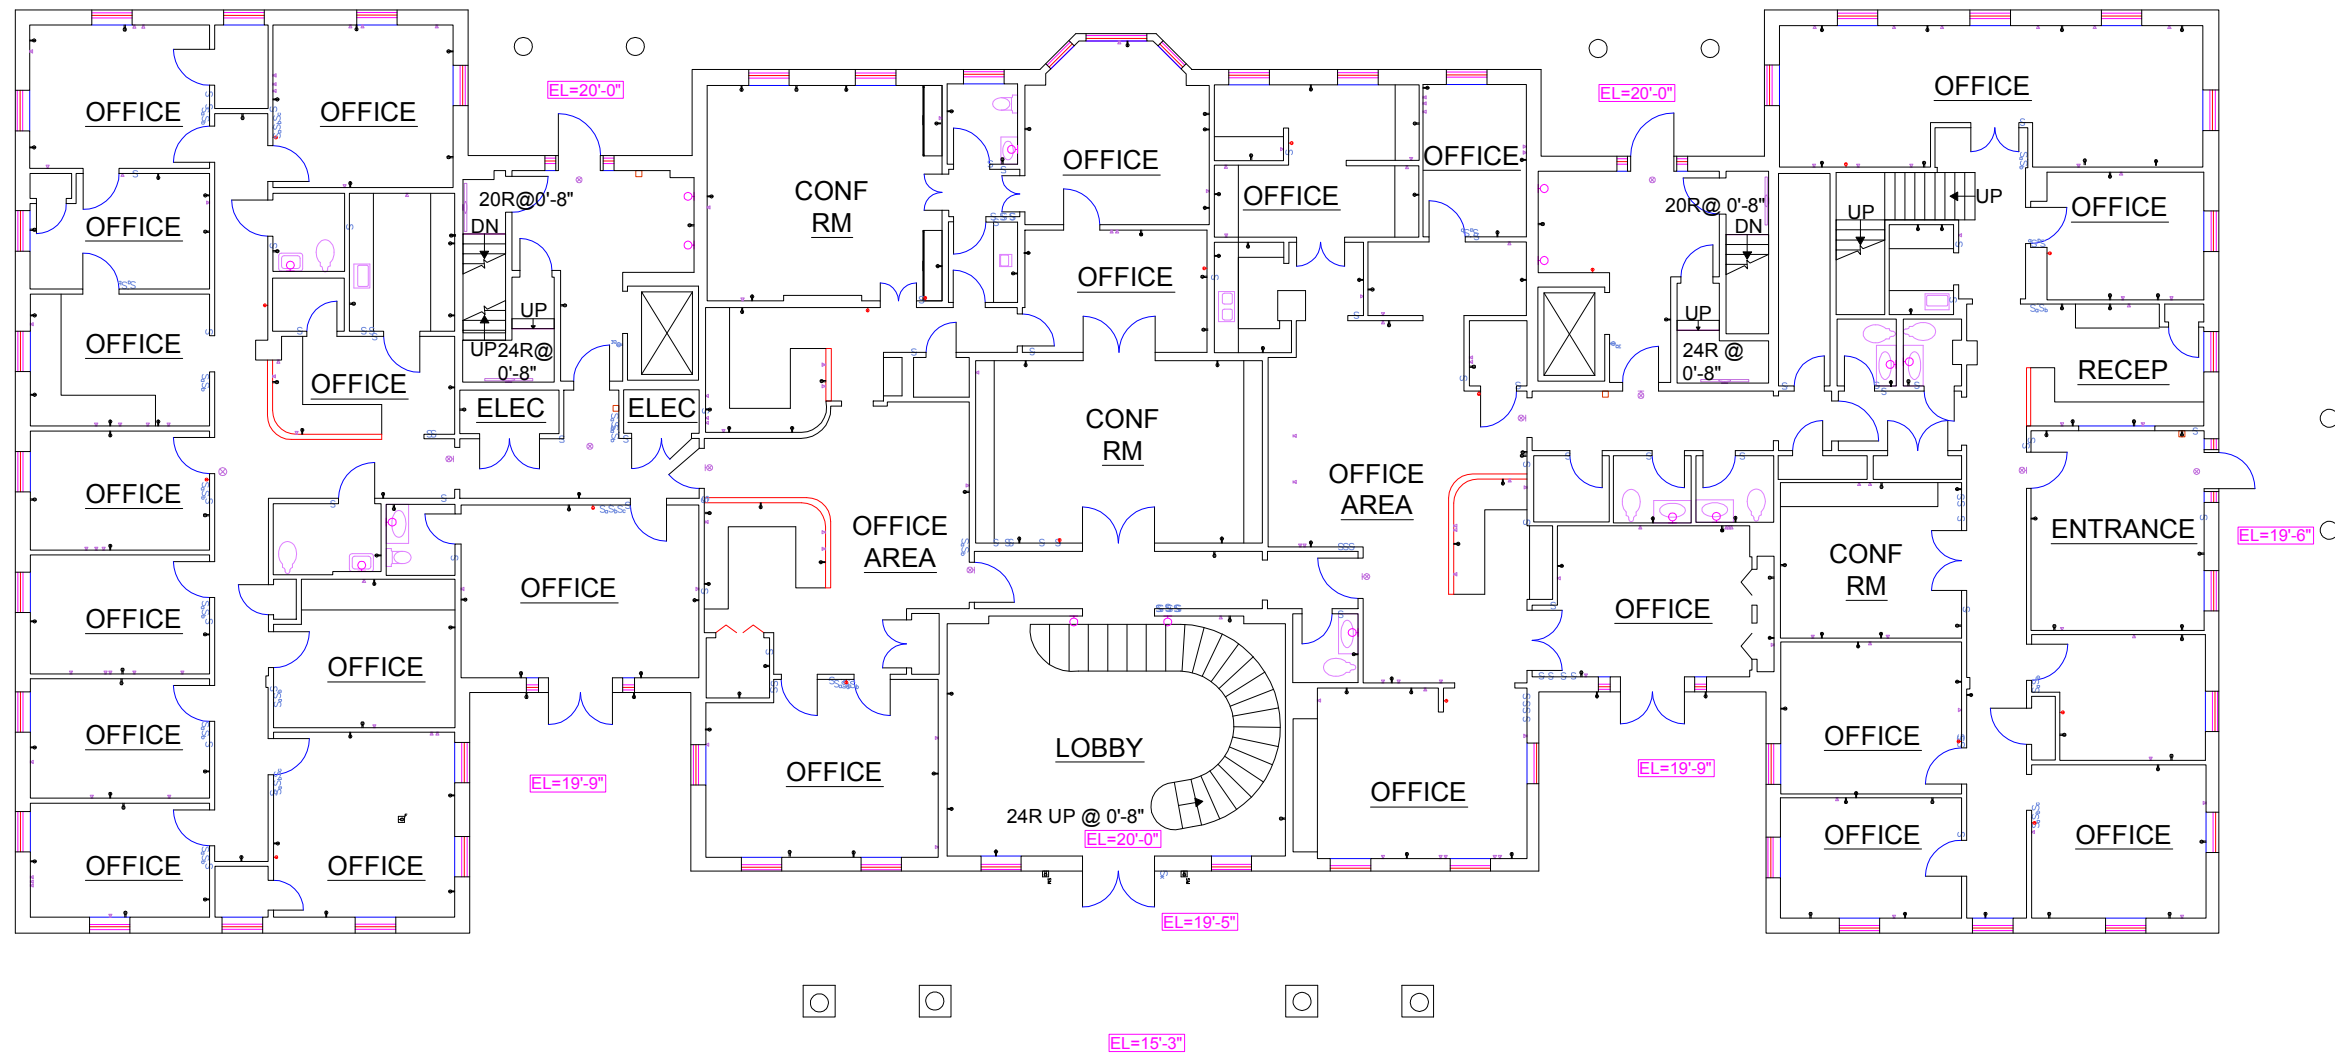

SCALE: 1/16" = 1' - 0"

Survey Accuracy: +/- 0.11 %

LASERTECH® is a registered US trademark of LASERTECH® FLOORPLANS LTD.
Copyright 1998-2010 LASERTECH® FLOORPLANS LTD. All Rights Reserved



TEL: (888) 393-6655
FILE: 8-002